


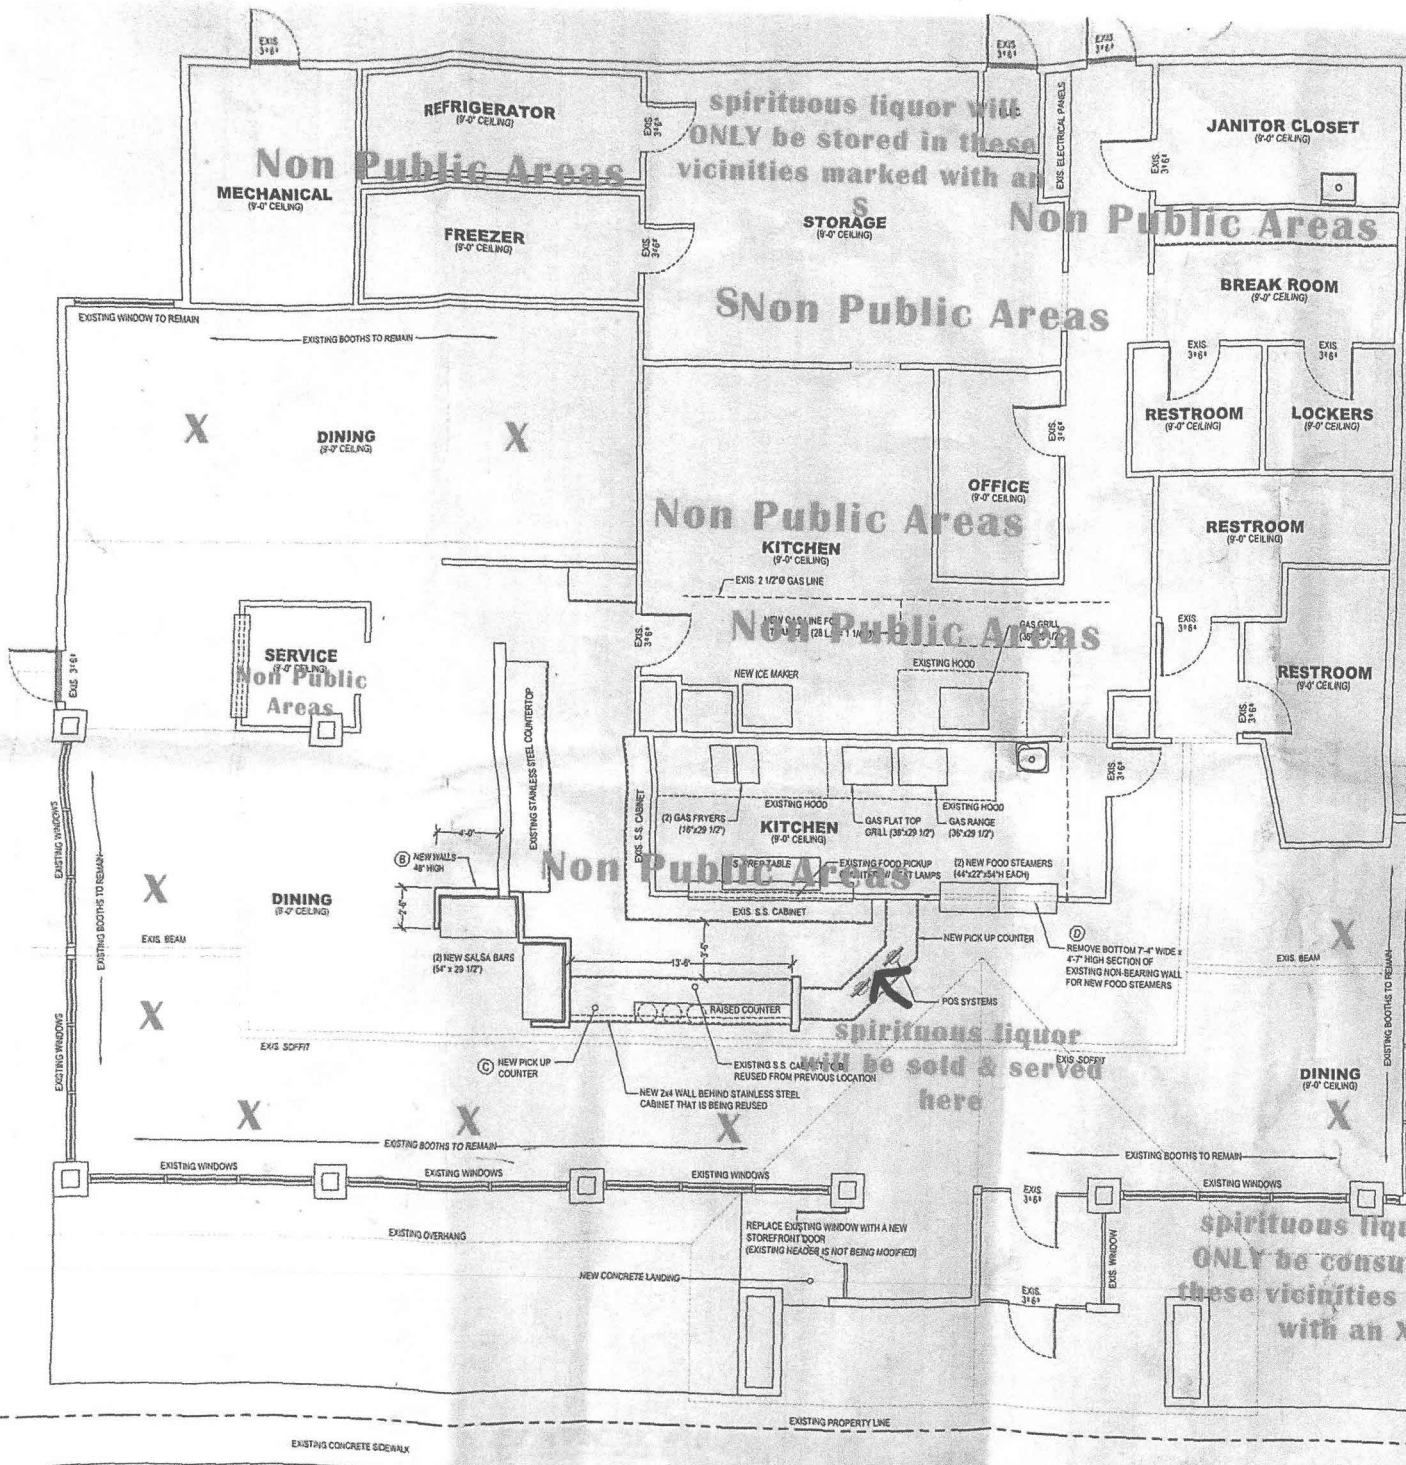

PROVIDE FIRE EXTINGUISHERS TYPE K
TYPE 2A0EC
PROVIDE KNOX BOX

RECEIVED
DEC 8 2019
BUILDING SAFETY

- ### SCOPE OF WORK
- NOTES:
- EXISTING ROOF STRUCTURE AND FOUNDATION ARE NOT BEING MODIFIED.
 - NO BEARING WALLS ARE BEING MODIFIED OR ALTERED.
 - BATHROOMS ARE NOT BEING MODIFIED.
 - DINING AREA SEATING IS NOT BEING INCREASED, PARKING IS NOT BEING MODIFIED.
 - SOME GAS COOKING APPLIANCES WERE REMOVED FROM PREVIOUS LAYOUT, TOTAL GAS DEMAND IS NOT BEING INCREASED.
 - ALL MANUFACTURER'S SPECS TO BE AT THE JOBSITE FOR INSPECTOR'S REVIEW.
- EXISTING BOOTHS AND TABLES WERE REMOVED AS PER DEMO PLAN.
 - BUILD PARTITION WALLS 48" HIGH FOR NEW SALSA BAR APPLIANCE LOCATION.
 - INSTALL NEW SERVICE AND PICK UP COUNTER.
 - REMOVE SECTION OF NON-BEARING WALL FOR NEW FOOD STEAMERS.
 - INSTALL NEW FANS AS PER ELECTRICAL PLANS.

REVIEWED FOR CODE COMPLIANCE

The Approval of the plans and specifications shall not be construed to be a permit, or an approval of, any violation of any codes or ordinances of the City of Yuma. The issuance of a permit based upon plans and specifications shall not prevent the BUILDING OFFICIAL from thereafter requiring the correction of errors or omissions in said plans and specifications.

Thomas R. Hill 12-5-19
Building Official or Authorized Designee Date



NOTICE - The approved set of the plans shall be maintained on the construction site at all times during construction.

FLOOR PLAN

SCALE: 1/4" = 1'-0"

20 OCT 28 11:41 AM '19